


SC-C-A1

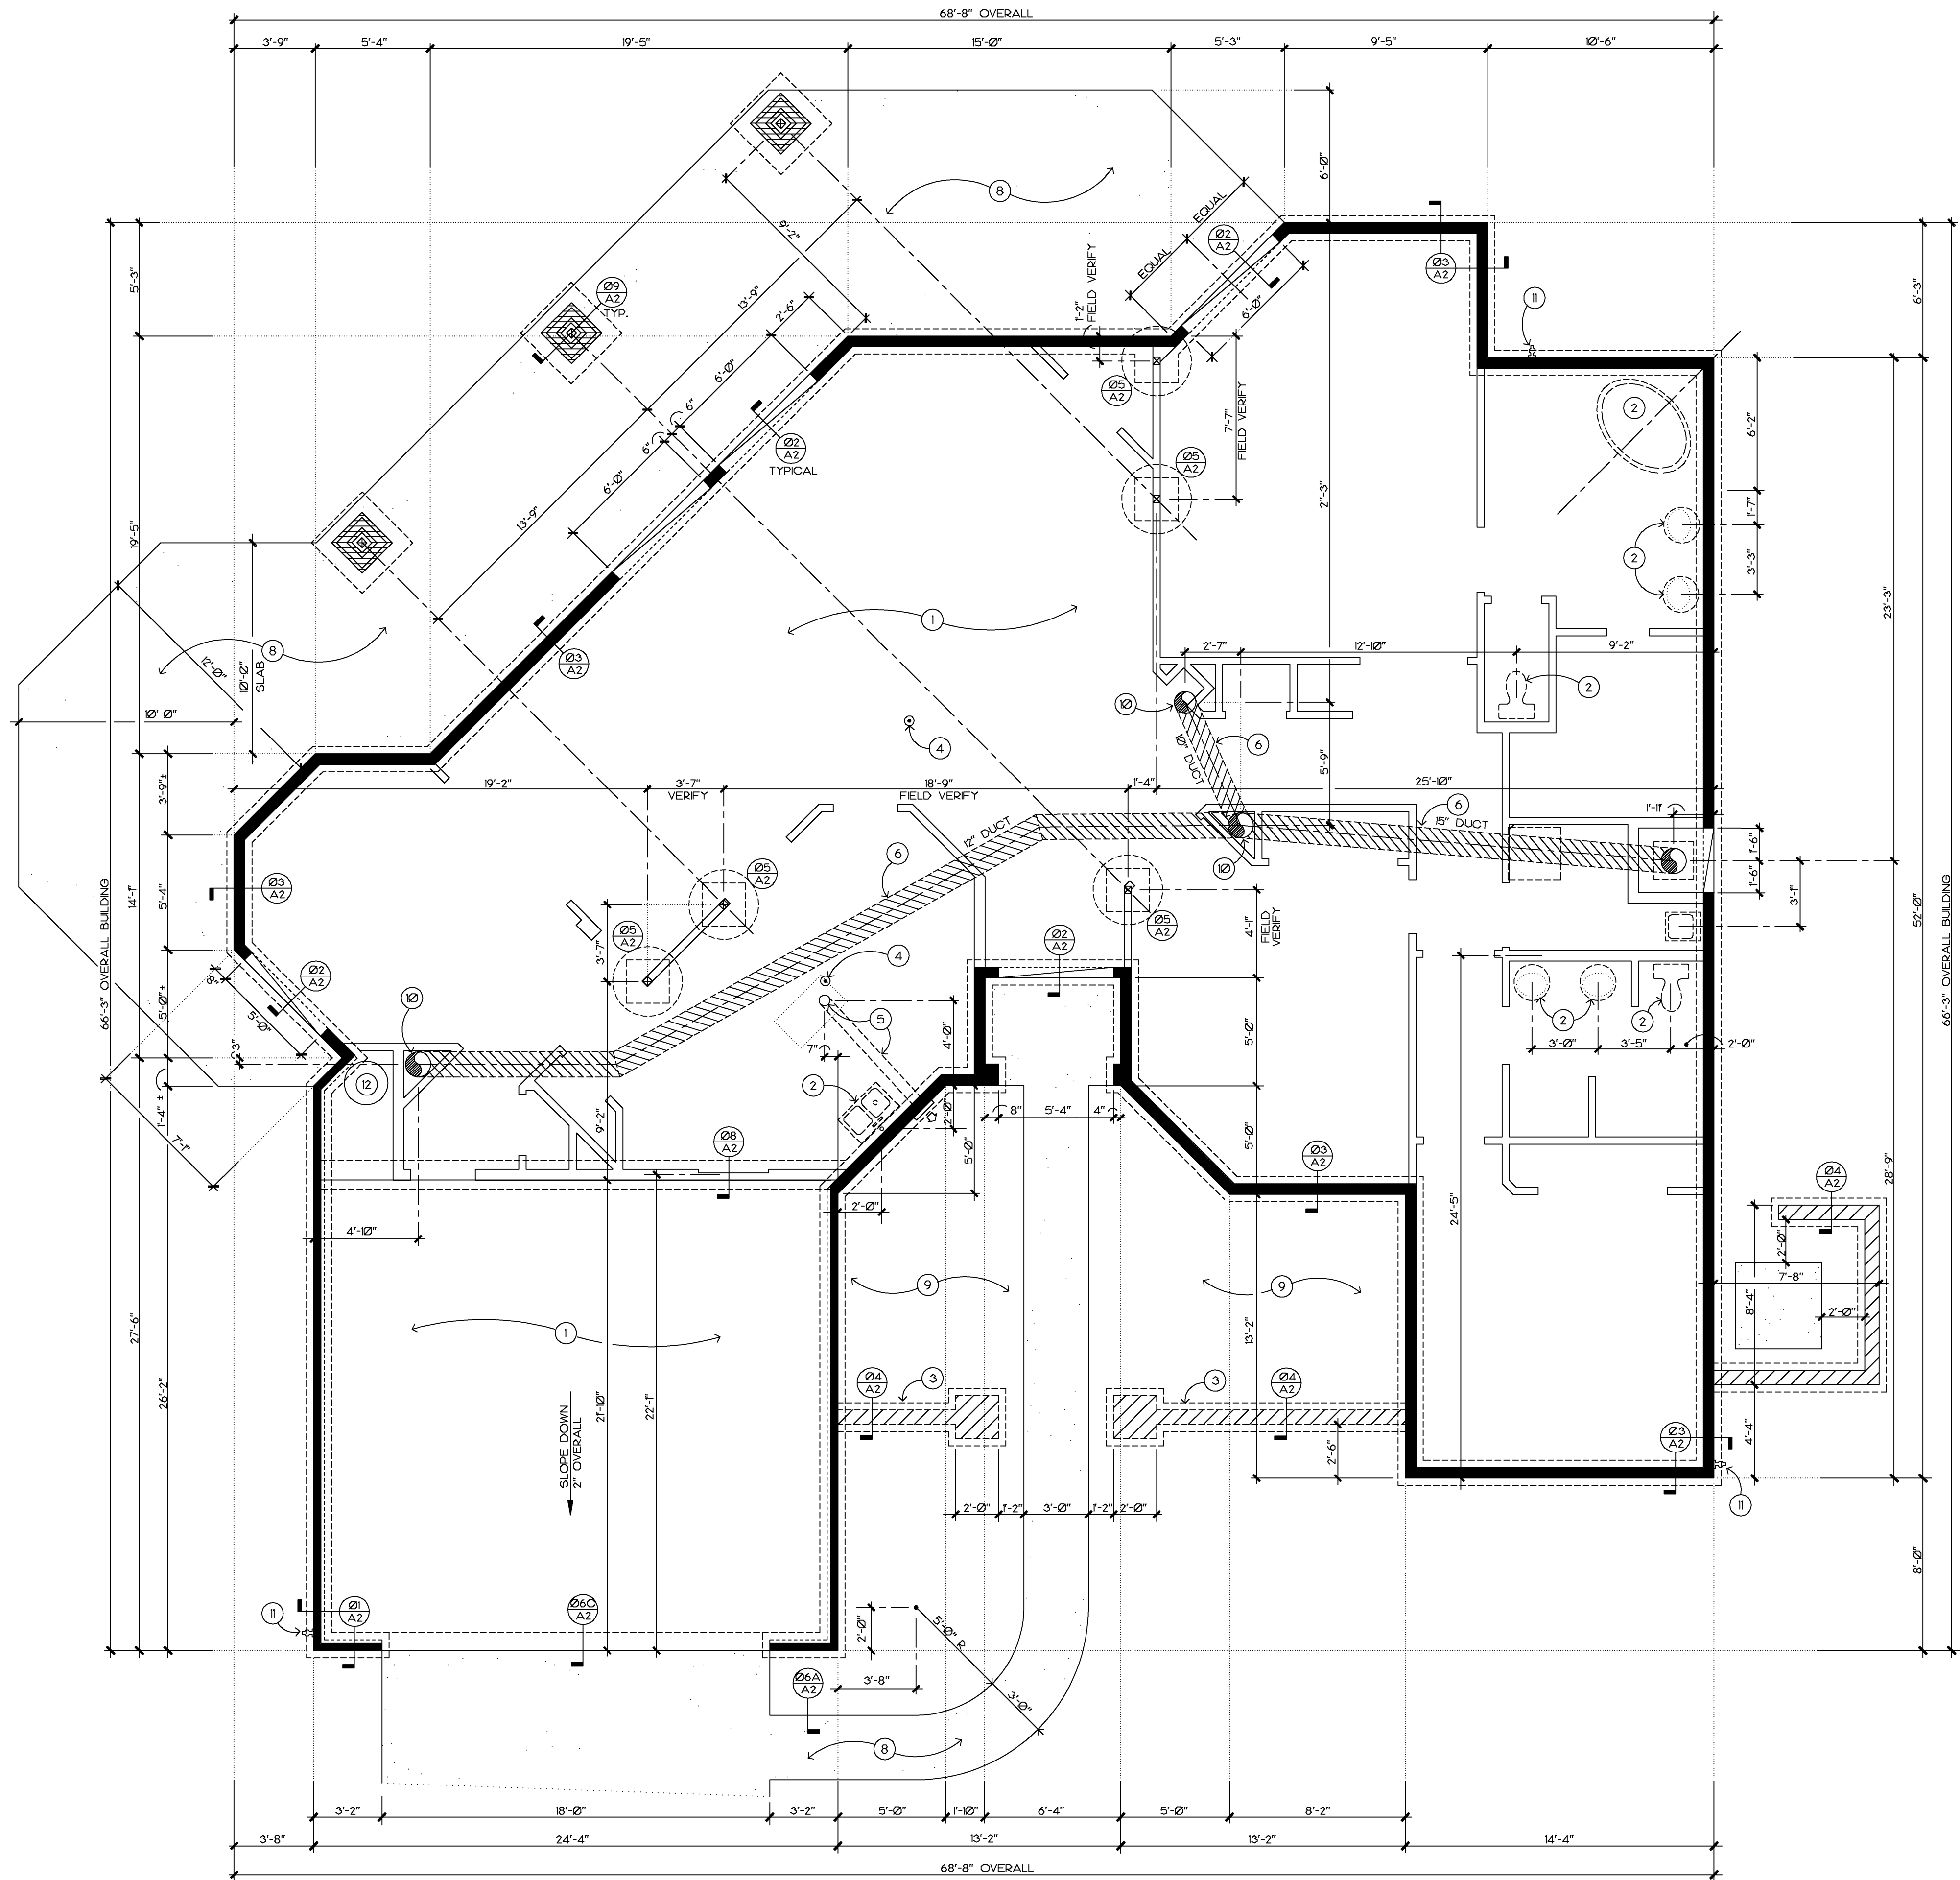

FOUNDATION PLAN

SCALE: 1/4" = 1'-0"

KEYED NOTES:

- 1 4" CONCRETE SLAB OVER 4" A.B.C. FILL
- 2 PLUMBING FIXTURE LOCATION
- 3 OPTIONAL MASONRY SCREEN WALL
- 4 ELECTRICAL FLOOR OUTLET - SEE ELECTRICAL PLAN SHEET A8
- 5 UNDERGROUND EXHAUST DUCT FOR RANGE TOP - EXIT TO THE EXTERIOR
- 6 UNDERSLAB RETURN AIR DUCT
- 7 -
- 8 4" CONCRETE SLAB OVER 4" A.B.C. FILL
- 9 OPEN PLANTING AREA
- 10 OPENING IN SLAB AT RETURN AIR DUCT
- 11 HOSE BBB LOCATION
- 12 WATER HEATER - SEE PLUMBING DWGS.

REVISIONS	BY
1	
2	
3	
4	
5	
6	
7	
8	


Sucasa "C"

THESE DRAWINGS ARE THE PROPERTY OF ALEXANDER AND SONS, INC. ANY REPRODUCTION OF THESE DRAWINGS OR ANY CONSTRUCTION WORK USING THESE ORIGINAL CONCEPTS BY ANY OTHERS THAN ALEXANDER AND SONS, INC. CONSTITUTES AN INFRINGEMENT OF OUR COPYRIGHT AND WILL BE SUBJECT TO LEGAL ACTION.

Alexander Homes

Alexander Homes is a division of Alexander & Sons, Inc.

18934 AVENIDA DEL RAY
RIO VERDE, ARIZONA 85255
(602) 471-2700 or 991-3420
FAX: (602) 471-7609

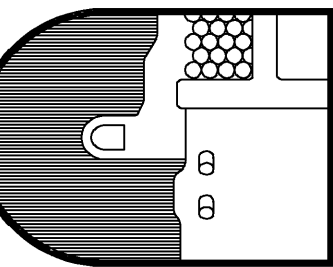

DRAWN A.C.P.
CHECKED M.C.
DATE =
SCALE AS SHOWN
JOB NO. =
SHEET =

A1

OF 08 SHEETS

SU CASA "C" - GAR. LEFT